


SEPTIC TANK WITH UP FLOW FILTERS

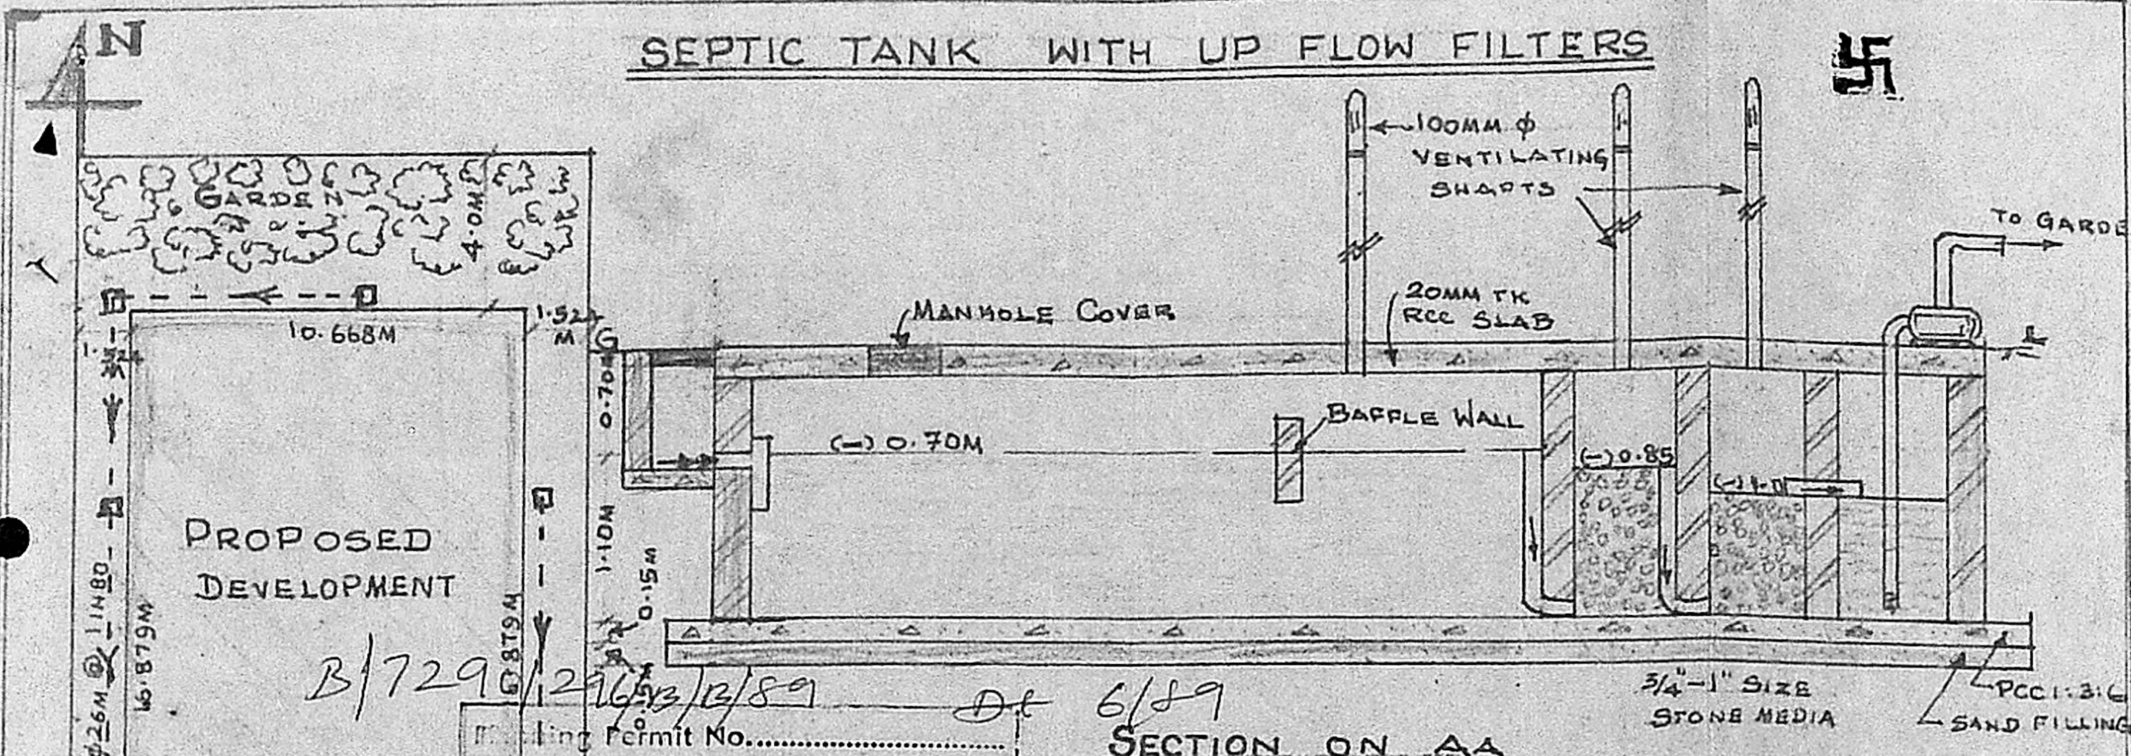

SECTION ON AA

B/7290/29/13/89 Dt 6/89

Building Permit No. ....


**APPROVED**

Subject to the conditions in this office letter

M. Krishnamoorthy  
20/6/89

FOR MEMBER SECRETARY  
MADRAS METROPOLITAN  
DEVELOPMENT AUTHORITY

SEPTIC TANK

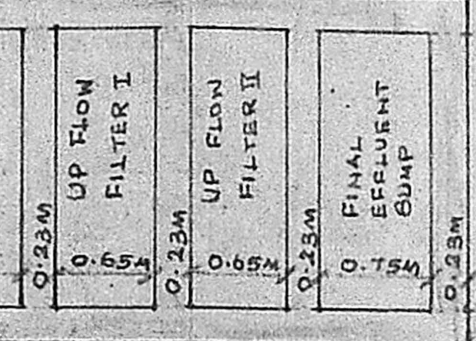

PLAN

SITE PLAN  
15/6/89  
SCALE: 1:200

P. Vasanth Kumar

OWNER

*K. Venugopal*

K. VENUGOPAL  
AEE (Retd)

CONSULTING CIVIL ENGINEER  
LICENSE SURVEYOR CLASS I  
CORPORATION OF MADRAS

3, NEELAKANDAR STREET  
NUNGAMBAKKAM (LAKE AREA)  
MADRAS-600 034

1320

PROPOSED RESIDENTIAL FLATS IN PLOT  
NO. 34 (DOOR NO. 46), RAGHAVA NAGAR, S.No.  
28/8, 160, HASTINAPURAM VILLAGE  
SAIDAPET TALUK.  
PLAN OF SEPTIC TANK  
SCALE: 1:50